


revisions		
DATE	NAME	DESCRIPTION
9-24-08	Angel	INITIAL COMPLETE (REVISED)

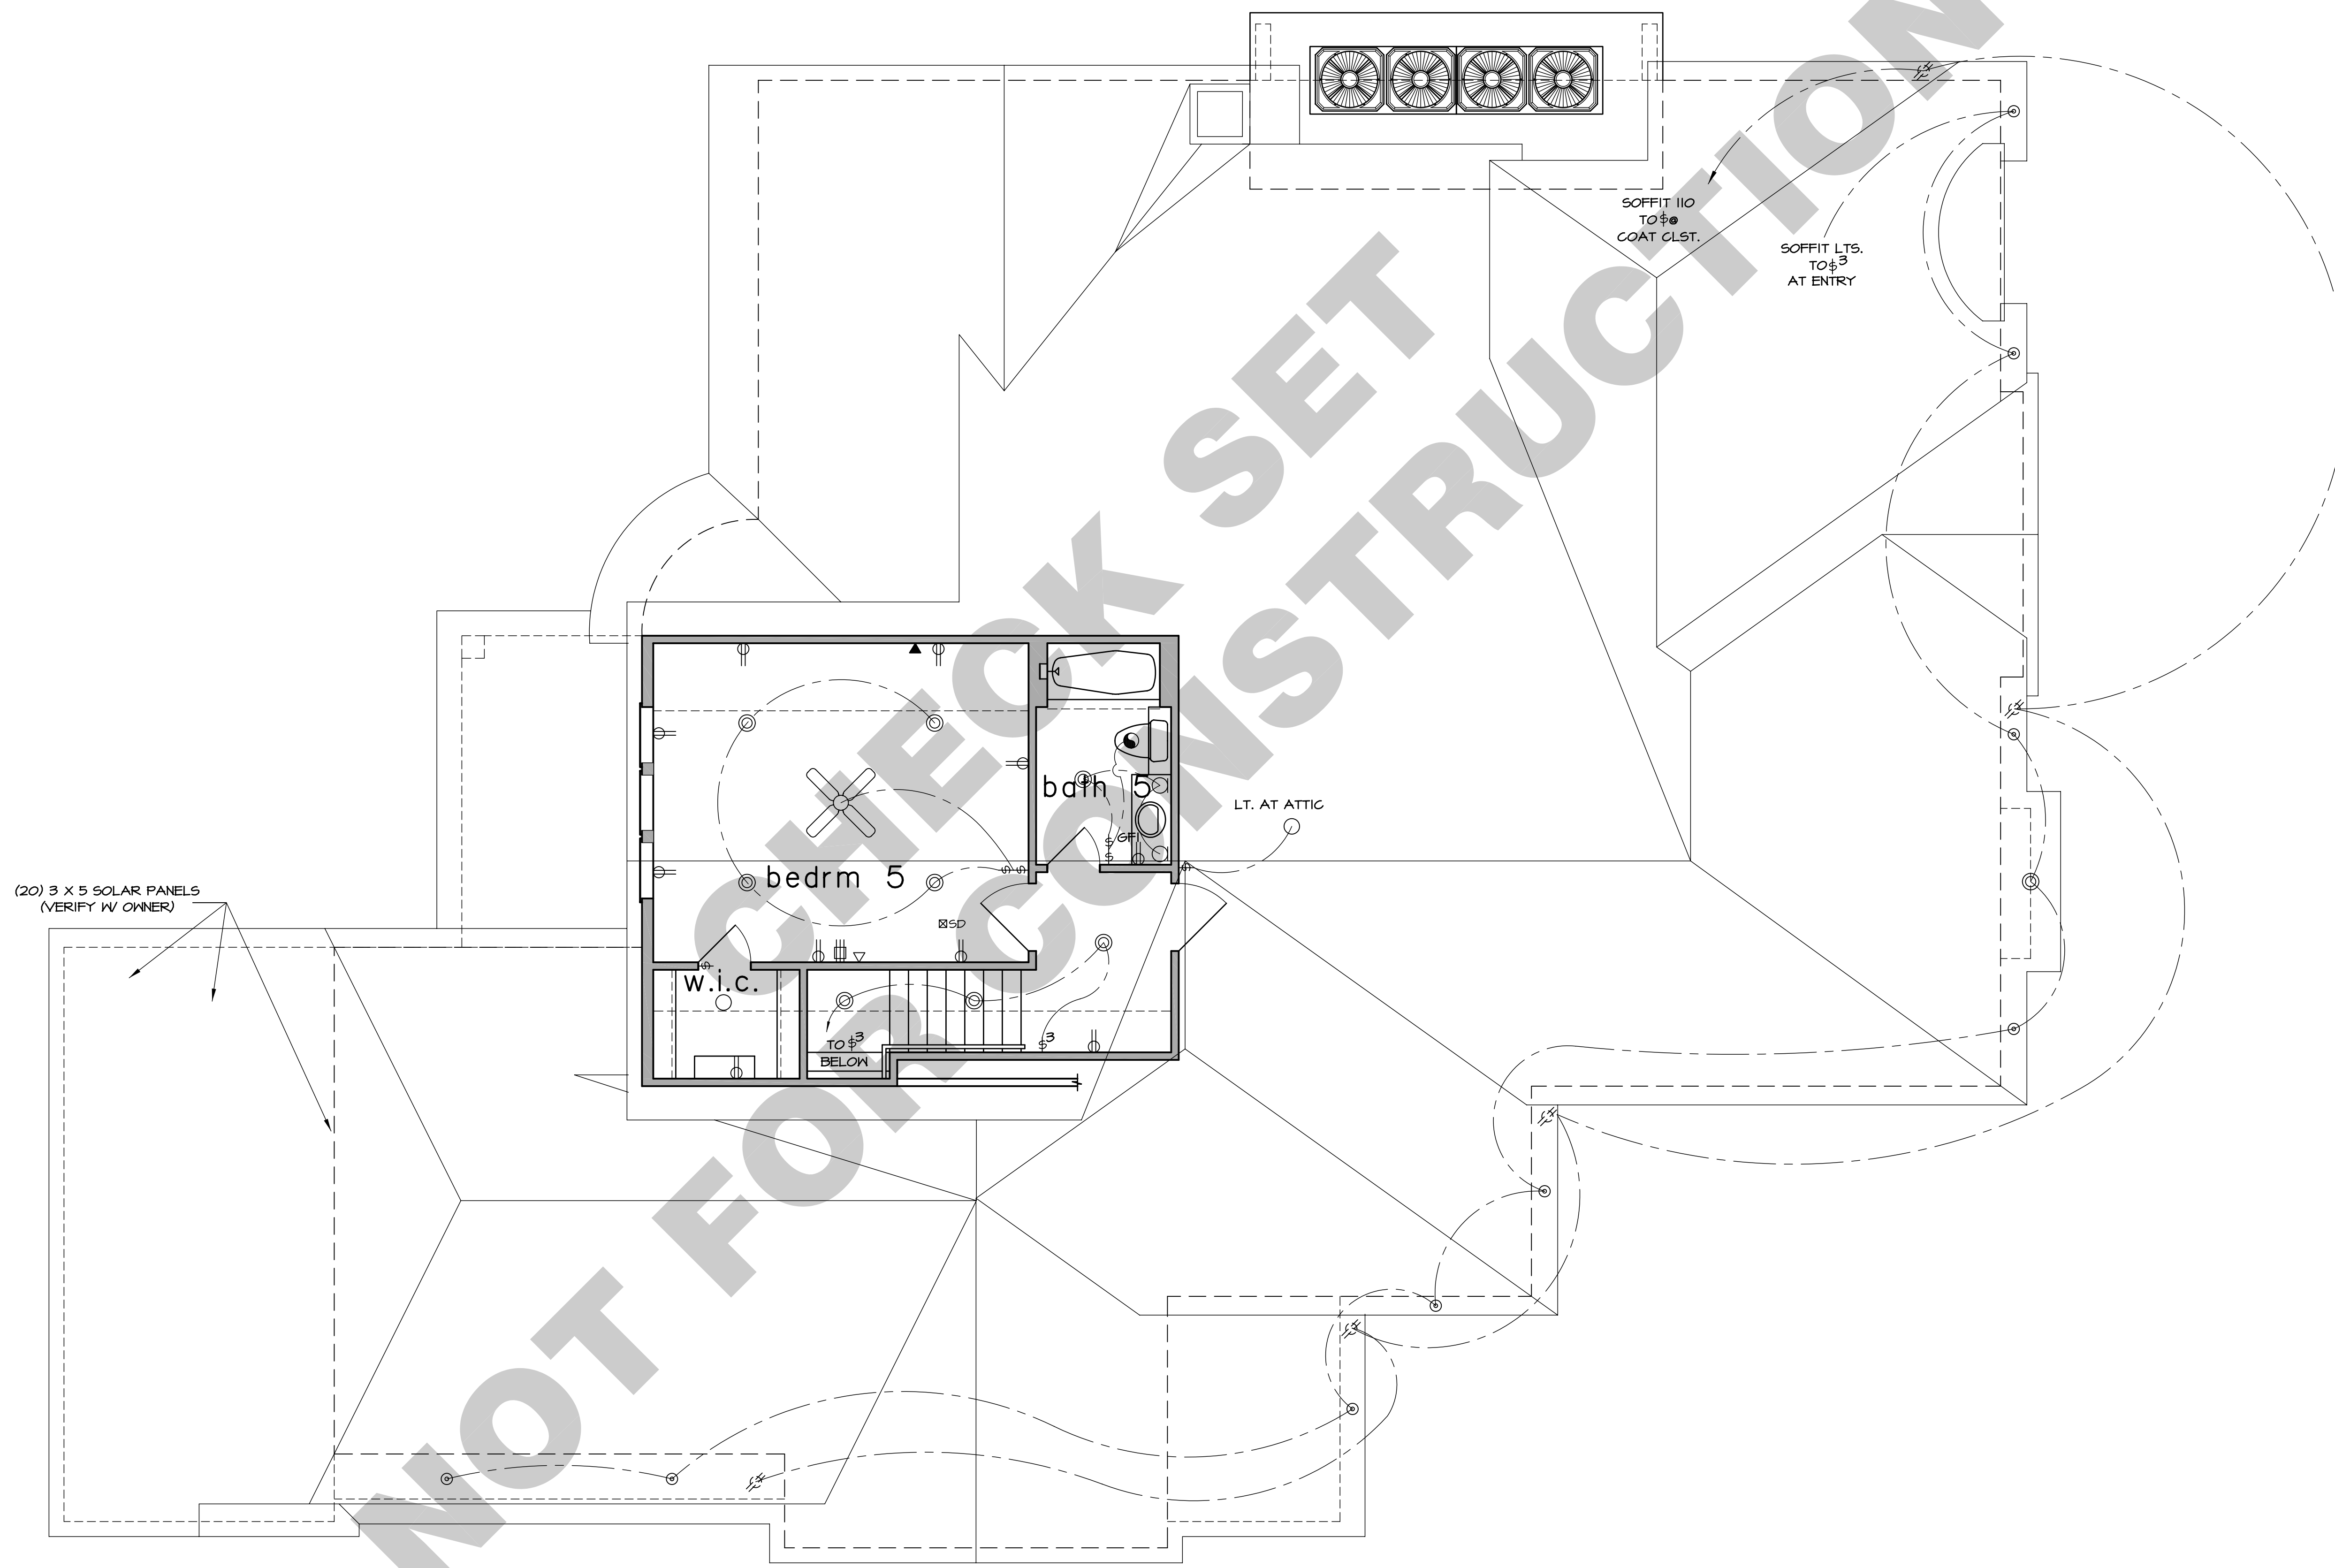

notes

- SMOKE DETECTORS REQUIRE 110V TO HOUSE WIRING W/ BATTERY BACKUP AND ARE INTERCONNECTED.
- VENT ALL EXHAUST FANS TO OUTSIDE.
- PROVIDE G.F.I. PROTECTION AS REQ'D.
- PROVIDE LIGHT FIXTURE AND SMOKE DETECTORS AT EACH WATER HEATER AND A/C UNIT LOCATION IN ATTIC.
- PROVIDE ELECTRIC DISCONNECT AT EACH A/C UNIT.
- ALLOW FOR A/C UNITS.
- PROVIDE LOW VOLTAGE CIRCUITS FOR BURGLAR ALARM SYSTEM.
- PROVIDE LOW VOLTAGE CIRCUITS FOR INTERCOM SYSTEM W/ BASE AND SPEAKER LOCATIONS BY OWNER.
- PROVIDE CIRCUITS FOR FUTURE POOL AND REAR YARD LIGHTING.
- ALLOW FOR OPTIONAL CENTRAL VACUUM SYSTEM.
- DIMMERS AT ALL BEDROOMS, DINING, LIBRARY, GAME ROOM, COMP. ALCOVE & KITCHEN.
- PROVIDE NETWORK JACKS AS PER OWNER.
- OUTLETS AT BEDROOMS TO BE ARC PROTECTED AND ON SEPERATE CIRCUITS FROM CLG. FANS.

third floor electrical plan

SCALE: 1/4" = 1'-0"